



OUTDOOR LIGHTING PLAN

1" = 20'-0"

Schedule									
Symbol	Label	QTY	Manufacturer	Catalog	Number Lamps	Lamp Output	Polar Plot	LLF	Input Power
	B	4	RAB Lighting Inc.	SLIM17FAFC60_4K at 0% CCT Setting	1	8190		1	58.39



Luminaire Locations									
Location								Aim	
No.	Label	X	Y	Z	MH	Orientation	Tilt	X	Y
2	B	215.50	149.50	15.00	15.00	70.00	0.00	215.50	149.50
3	B	264.00	126.50	15.00	15.00	345.00	0.00	264.00	126.50
4	B	202.00	193.50	15.00	15.00	70.00	0.00	202.00	193.50
1	B	169.50	205.50	15.00	15.00	350.00	0.00	169.50	205.50

Statistics						
Description	Symbol	Avg	Max	Min	Max/Min	Avg/Min
4 Jackson Street	+	0.0 fc	0.0 fc	0.0 fc	N/A	N/A
7 Jackson Street	+	0.0 fc	0.0 fc	0.0 fc	N/A	N/A
Jackson Street	+	0.0 fc	0.0 fc	0.0 fc	N/A	N/A
Parking Lot	+	1.0 fc	12.1 fc	0.0 fc	N/A	N/A
Railroad	+	0.0 fc	1.5 fc	0.0 fc	N/A	N/A
2 Jackson Street	+	0.0 fc	0.0 fc	0.0 fc	N/A	N/A

OUTDOOR PHOTOMETRIC REPORT
CATALOG: SLIM17FAFC60_4K AT 0% CCT SETTING
Manufacturer: RAB Lighting Inc.
Test Lab: Belling Test Laboratory Co., LTD
Catalog: SLIM17FAFC60_4K at 0% CCT Setting
Description:
Lamp Output: 1 lamp, rated Lumens/lamp: 8189.8
Input Wattage: 58.39
Luminous Opening: Point
Max Cd: 3,060.2 at Horizontal: 0°, Vertical: 57°
CUTOFF CLASS: Full Cutoff
Roadway Class: VERY SHORT, TYPE III
Efficiency: 85.9%

AcuityBrands

No
Photo
Available

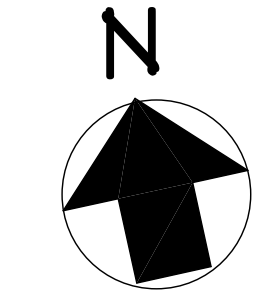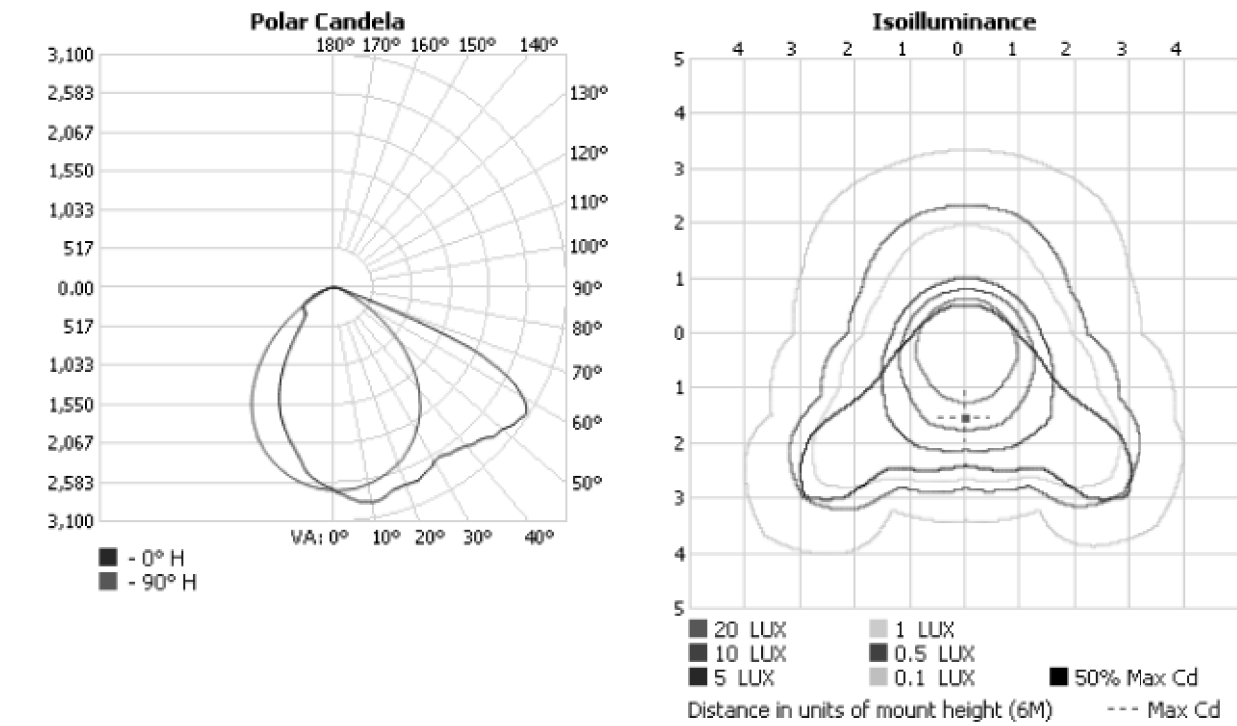

NO.	DESCRIPTION	BY	DATE
1			
2			
3			
4			

SHEET TITLE:	OUTDOOR LIGHTING PLAN
--------------	-----------------------

PROJECT DESCRIPTION:	MAPLE MILL APARTMENTS
----------------------	-----------------------

DRAWINGS PROVIDED BY:	MAPLE MILL LLC
-----------------------	----------------

DATE:	11/22/22
-------	----------

SCALE:	1" = 20'-0"
--------	-------------

SHEET:	L1
--------	----