

TOWN OF WILISTON, VERMONT

CONTRACT DRAWINGS FOR

ESSEX JUNCTION WASTEWATER TREATMENT FACILITY DRYING BEDS

JANUARY, 2026


SELECTBOARD
 TED KENNEY, CHAIR
 GRETA D'AGOSTINO, VICE CHAIR
 TERRY MACAIQ
 JEANNE JENSEN
 MIKE ISHAM

TOWN MANAGER
 ERIK WELLS

PUBLIC WORKS DIRECTOR
 BRUCE HOAR



PROJECT LOCATION

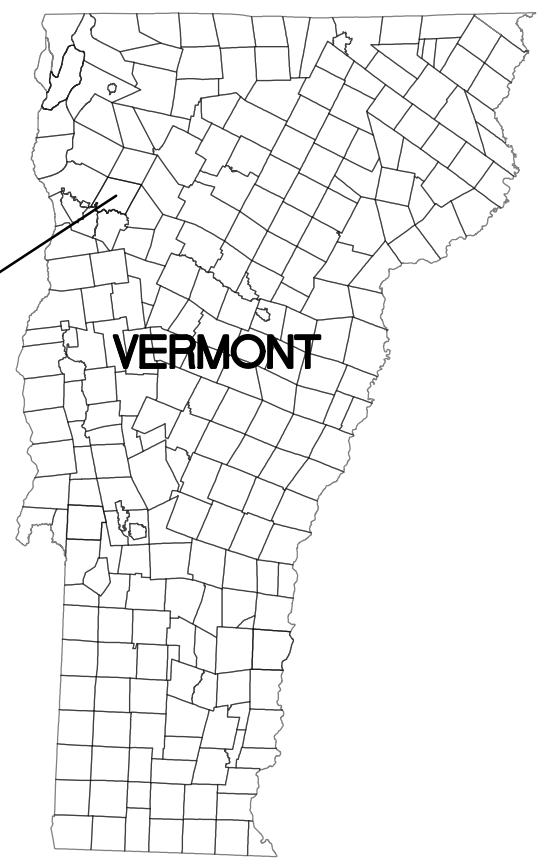

VERMONT

INDEX OF DRAWINGS

DRAWING No.	DRAWING TITLE
T	TITLE SHEET AND INDEX OF DRAWINGS
1	GENERAL CONSTRUCTION NOTES AND LEGEND
2	EXISTING CONDITION AND DEMOLITION PLAN
3	PROPOSED SITE PLAN
4	PROPOSED SECTIONS

LOCATION MAP
 SCALE: 1"=500'

These documents are copyrighted by Aldrich + Elliott (A+E), with all rights reserved. No duplication or distribution by anyone other than Blueprints Etc., or those authorized in writing by A+E to print and distribute these documents, is allowed by law. Violation of this copyright is a finable offense in Vermont and violators will be prosecuted. Copy shops and view rooms are specifically prohibited from making copies of these copyrighted documents for distribution and sale. View rooms may scan these documents for viewing only and bidders may purchase a CD that contains the documents in pdf format. However the stamped paper reproducible version of the documents will govern and prevail in the event of any discrepancy.






CHECKED	DESCRIPTION	DATE	No.

TOWN OF WILISTON, VERMONT

ESSEX JUNCTION WASTEWATER TREATMENT FACILITY DRYING BEDS

TITLE SHEET AND INDEX OF DRAWINGS

DESIGNED JRB	PROJECT NO. 25032
DRAWN EDS	DRAWING NO. T
CHECKED JRB	
DATE JAN. 2026	

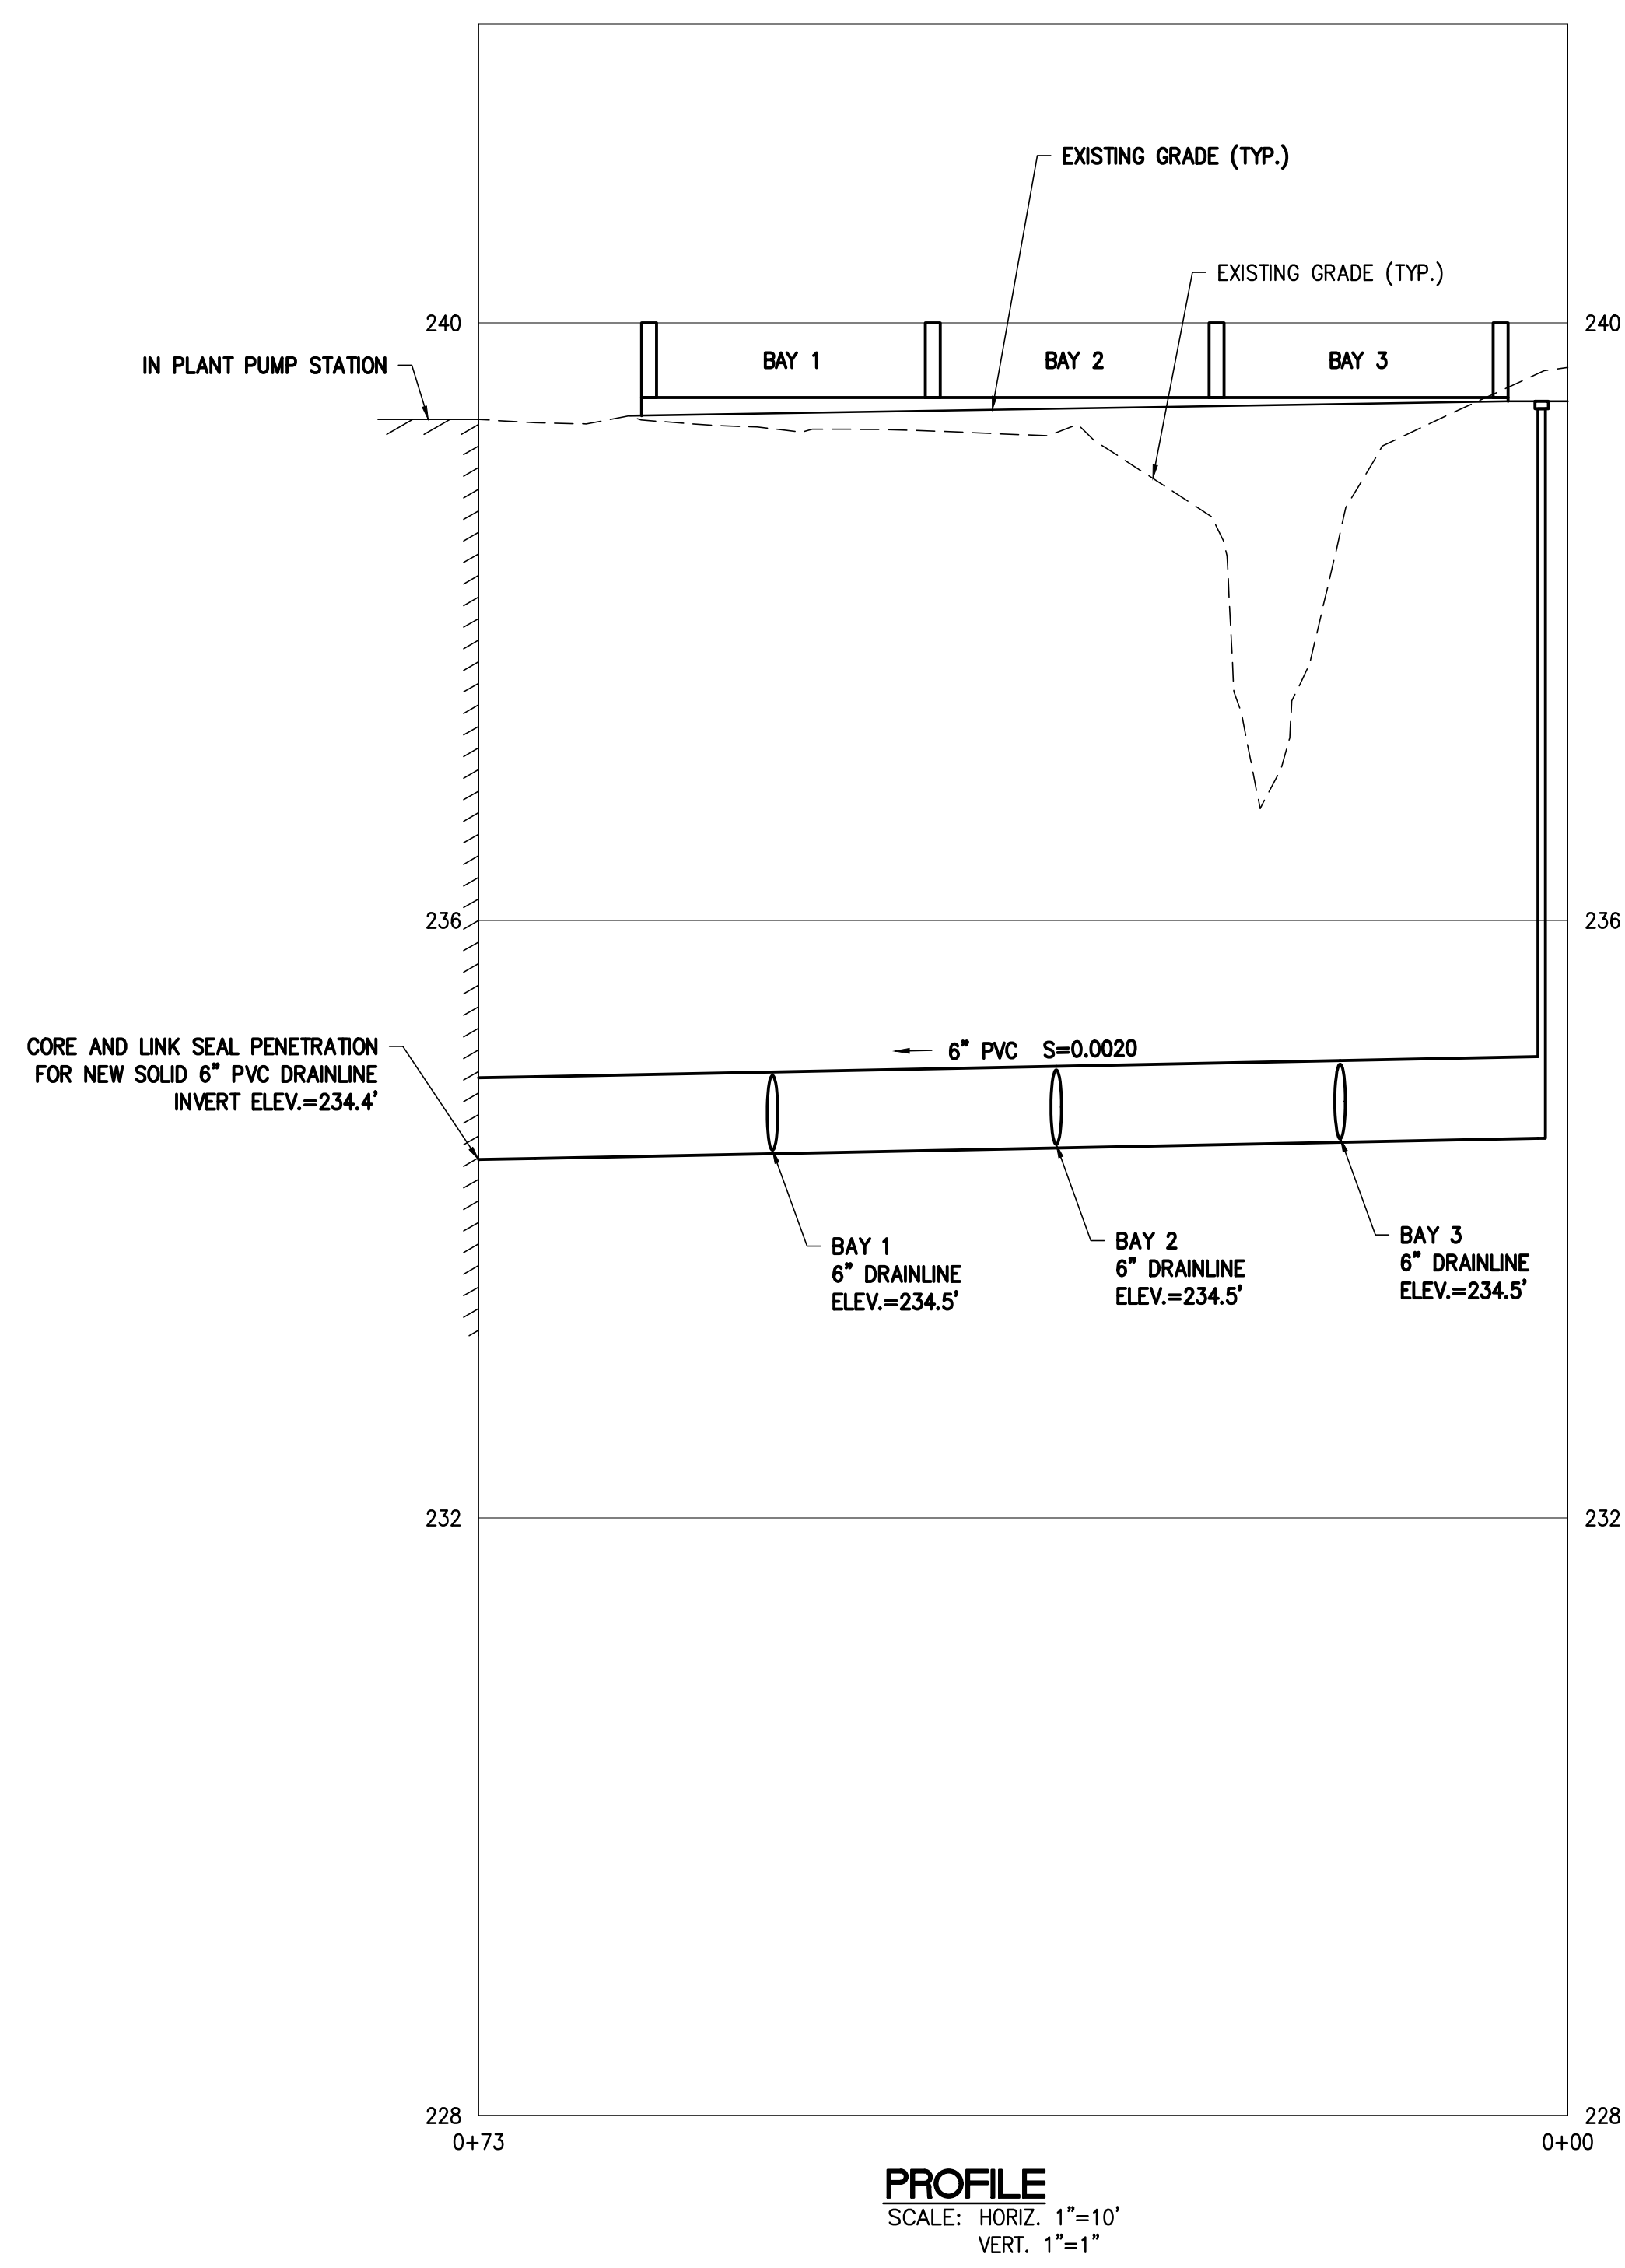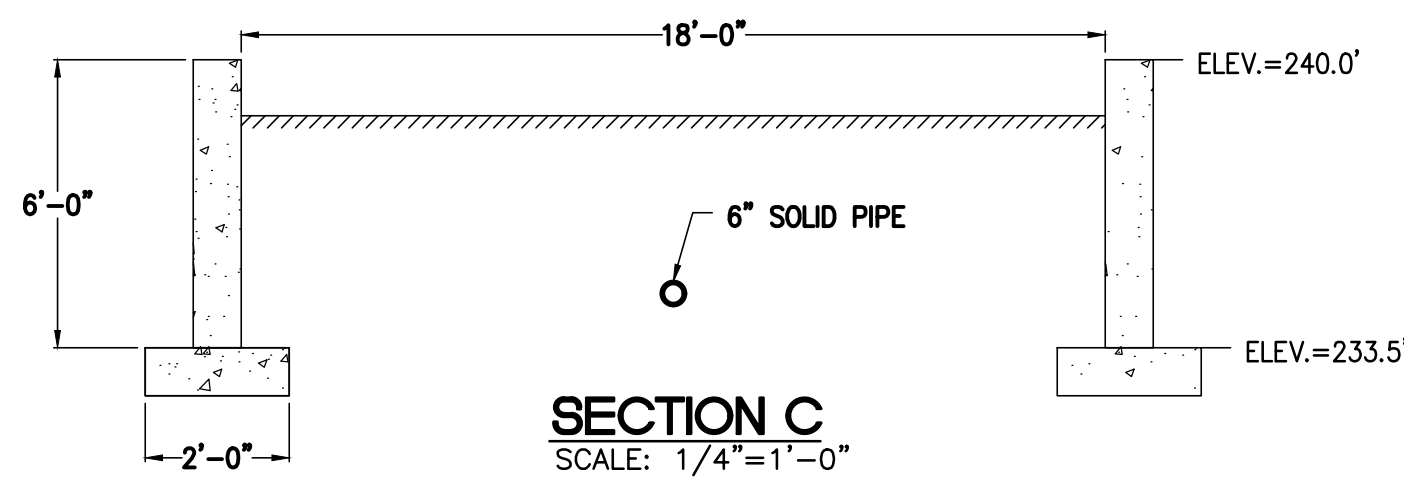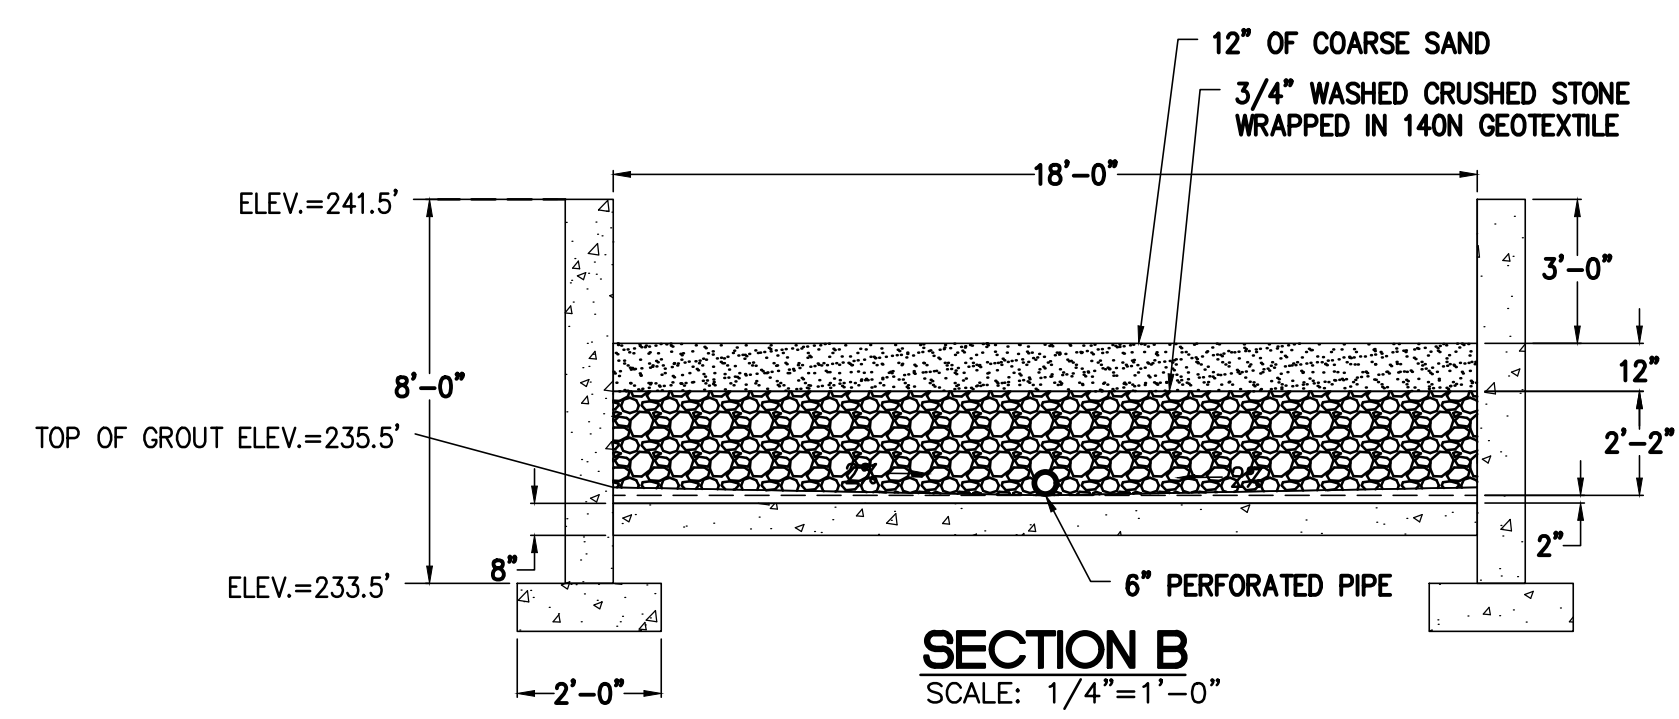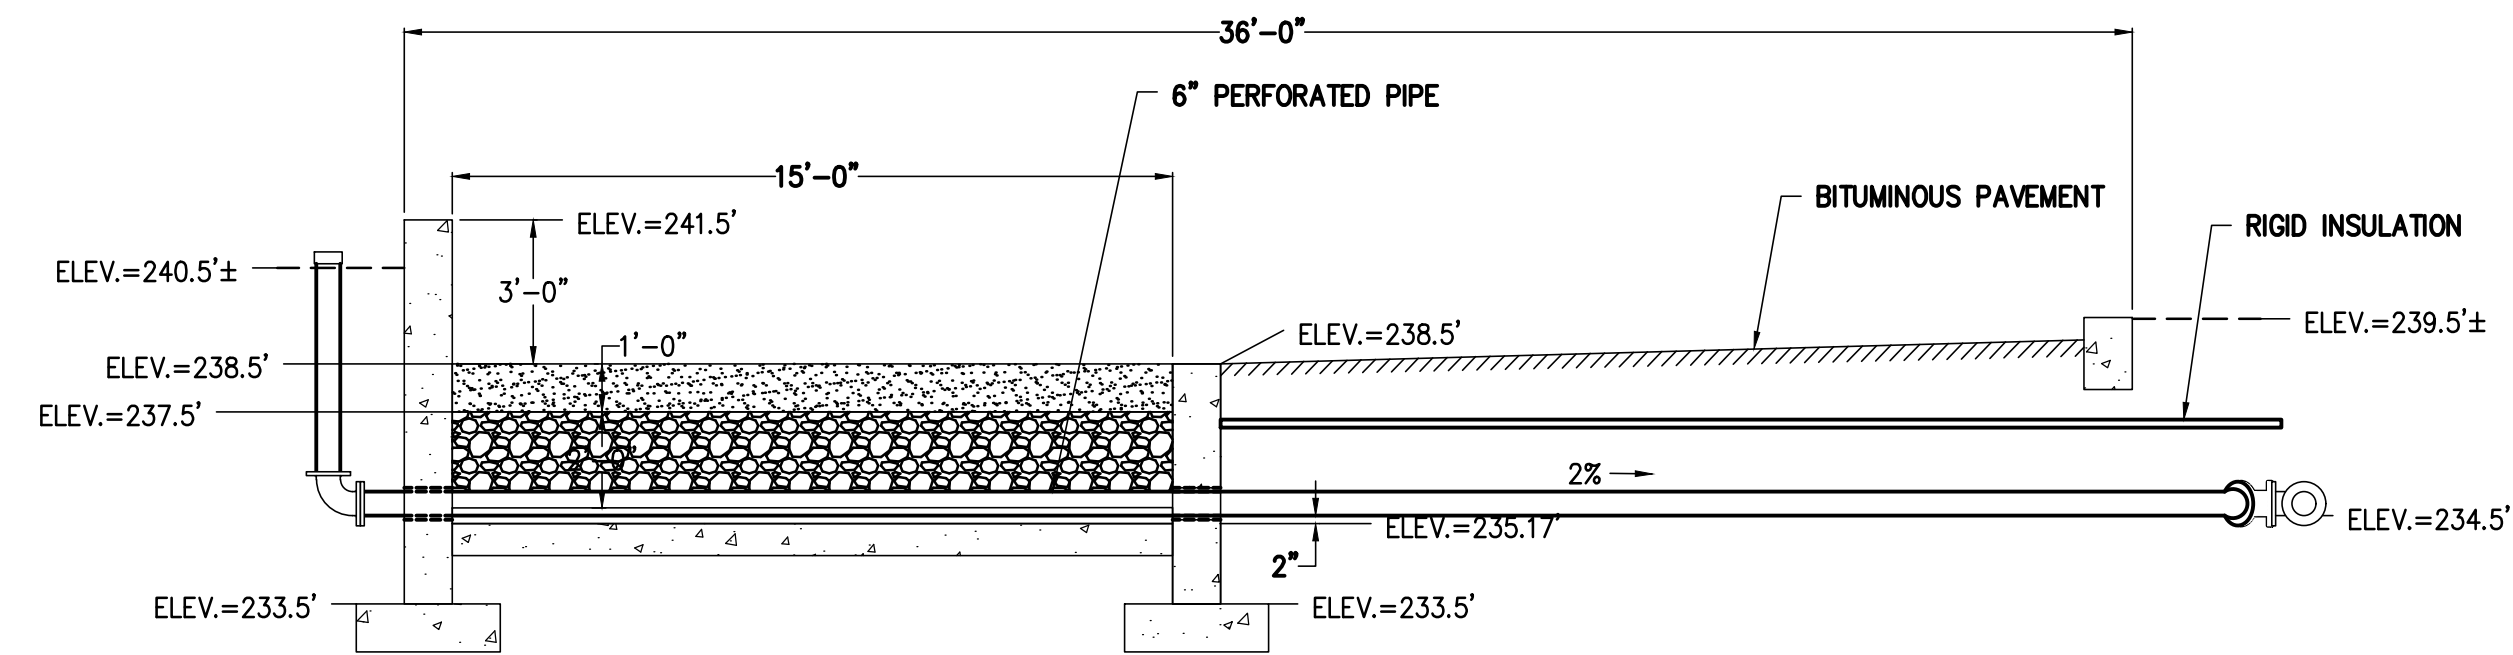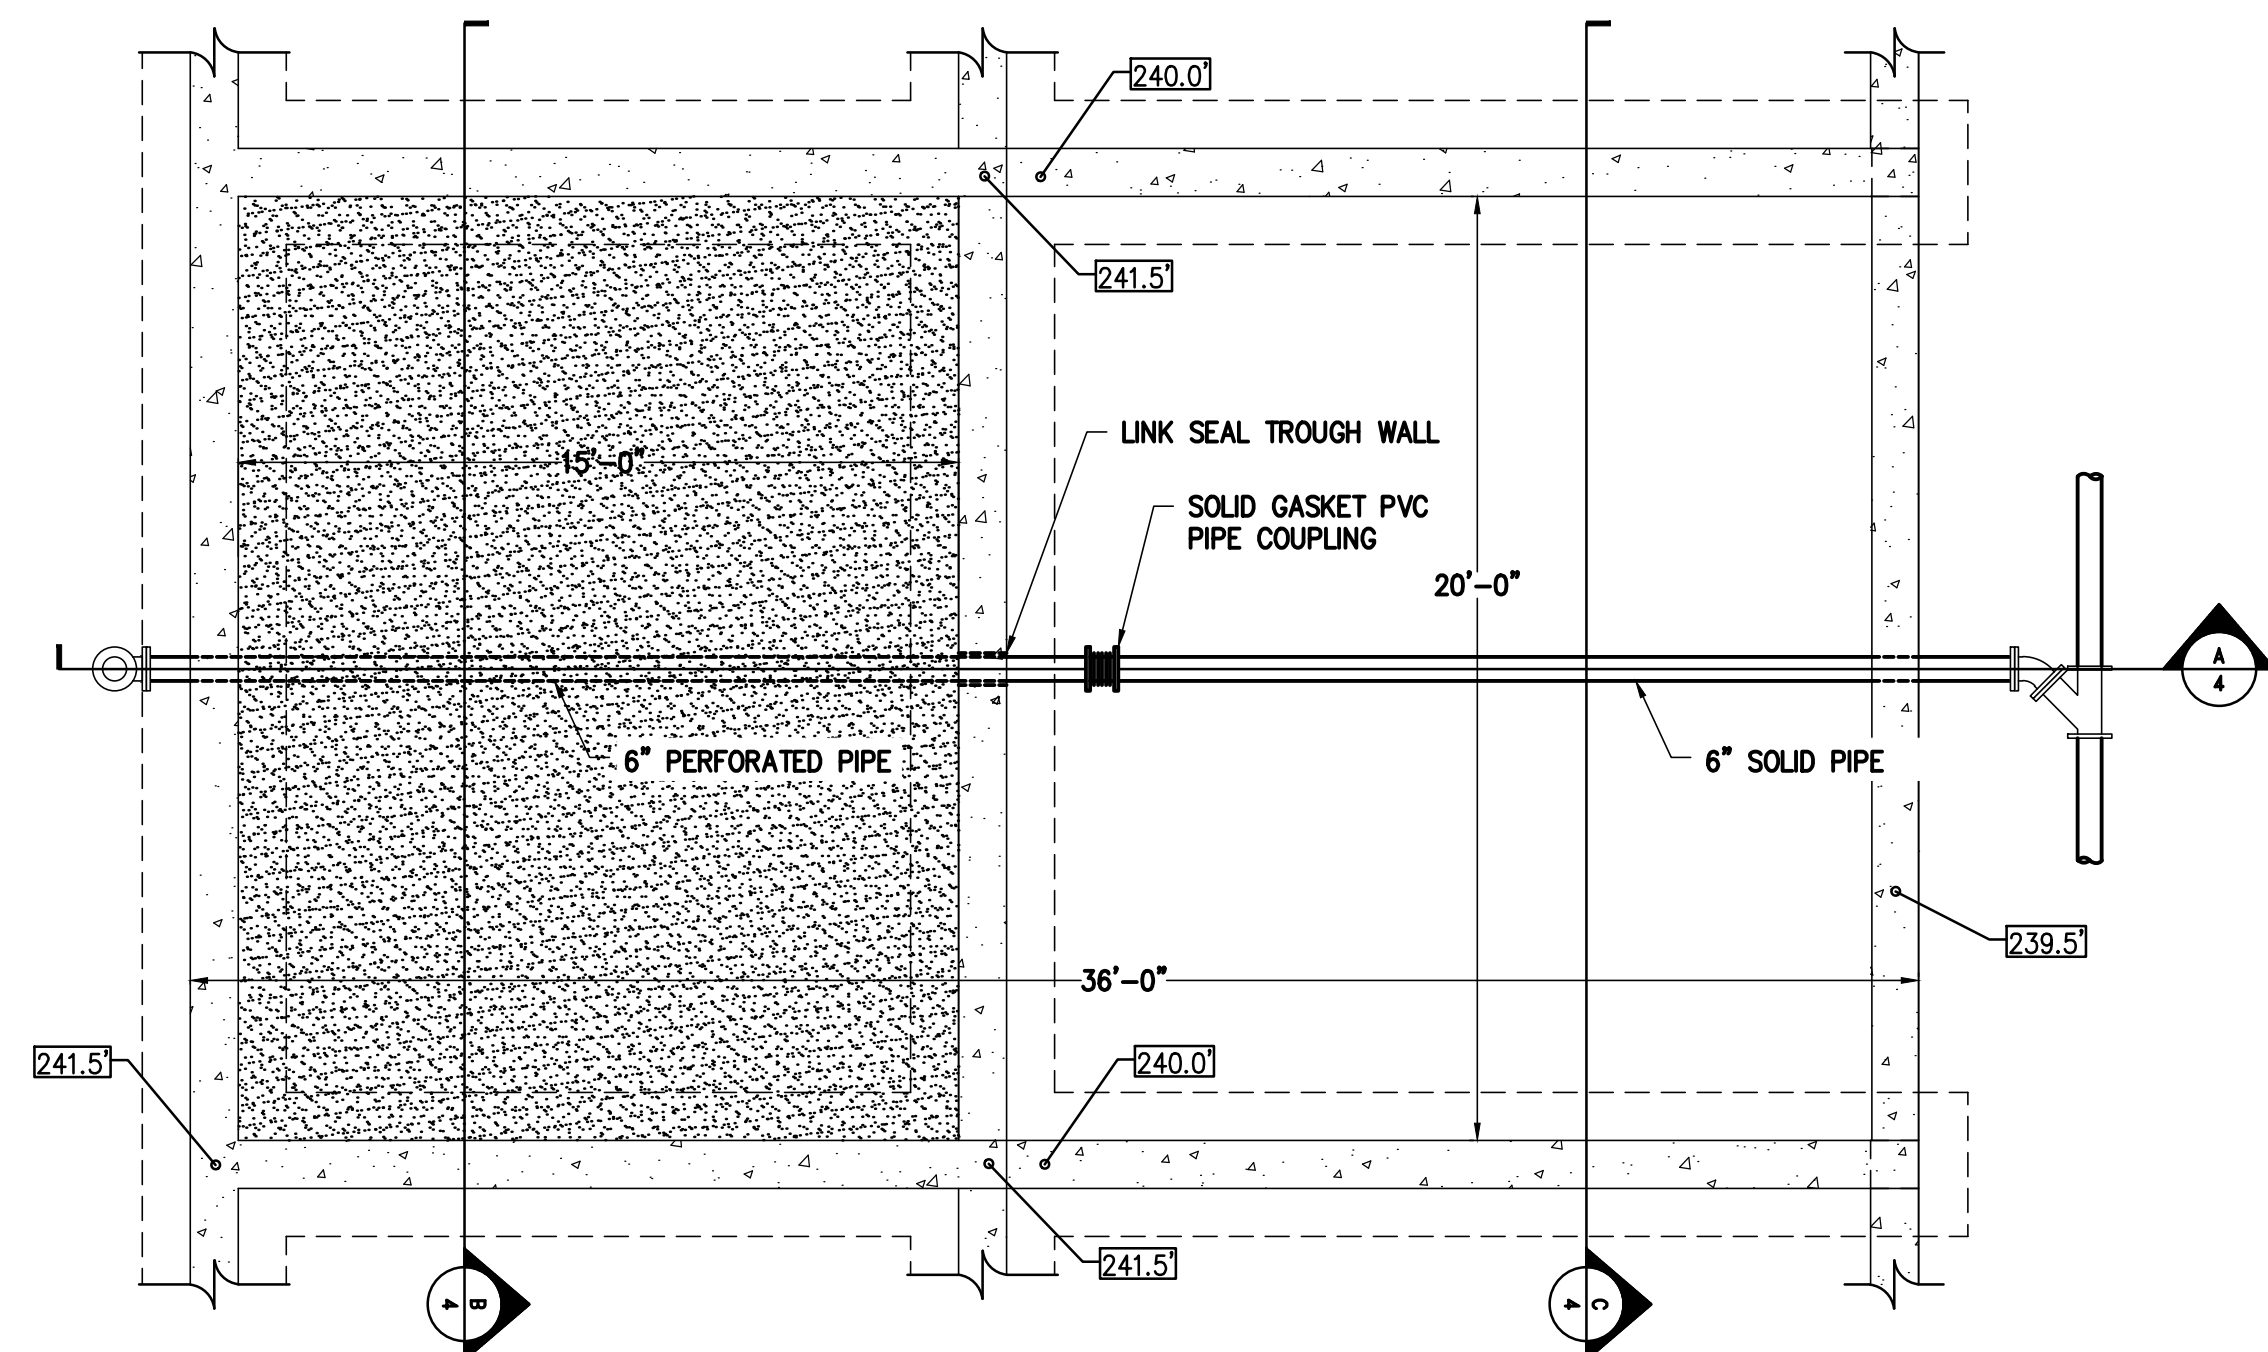

CHECKED	DESCRIPTION	DATE	No.

TOWN OF WILISTON, VERMONT
 ESSEX JUNCTION WASTEWATER TREATMENT FACILITY DRYING BEDS

PROPOSED SECTIONS

DESIGNED JRB	PROJECT NO. 25032
DRAWN EDS	DRAWING No.
CHECKED JRB	4
DATE JAN. 2026	

C:\Users\khanu\Documents\Aldrich + Elliott\Shared - Documents\CAD\essex\ESSEX JUNCTION WWTF SLUDGE DRYING BEDS\STEP 11\25032.dwg, 1/22/2026 3:55:02 PM








NO.	DATE	DESCRIPTION	CHECKED

TOWN OF
 WILISTON,
 VERMONT

ESSEX JUNCTION
 WASTEWATER
 TREATMENT
 FACILITY DRYING
 BEDS

PLAN & DETAILS

DESIGNED TCW	PROJECT NO. 25512
DRAWN TCW	DRAWING NO. S2
CHECKED BAN	DATE 03/12/26

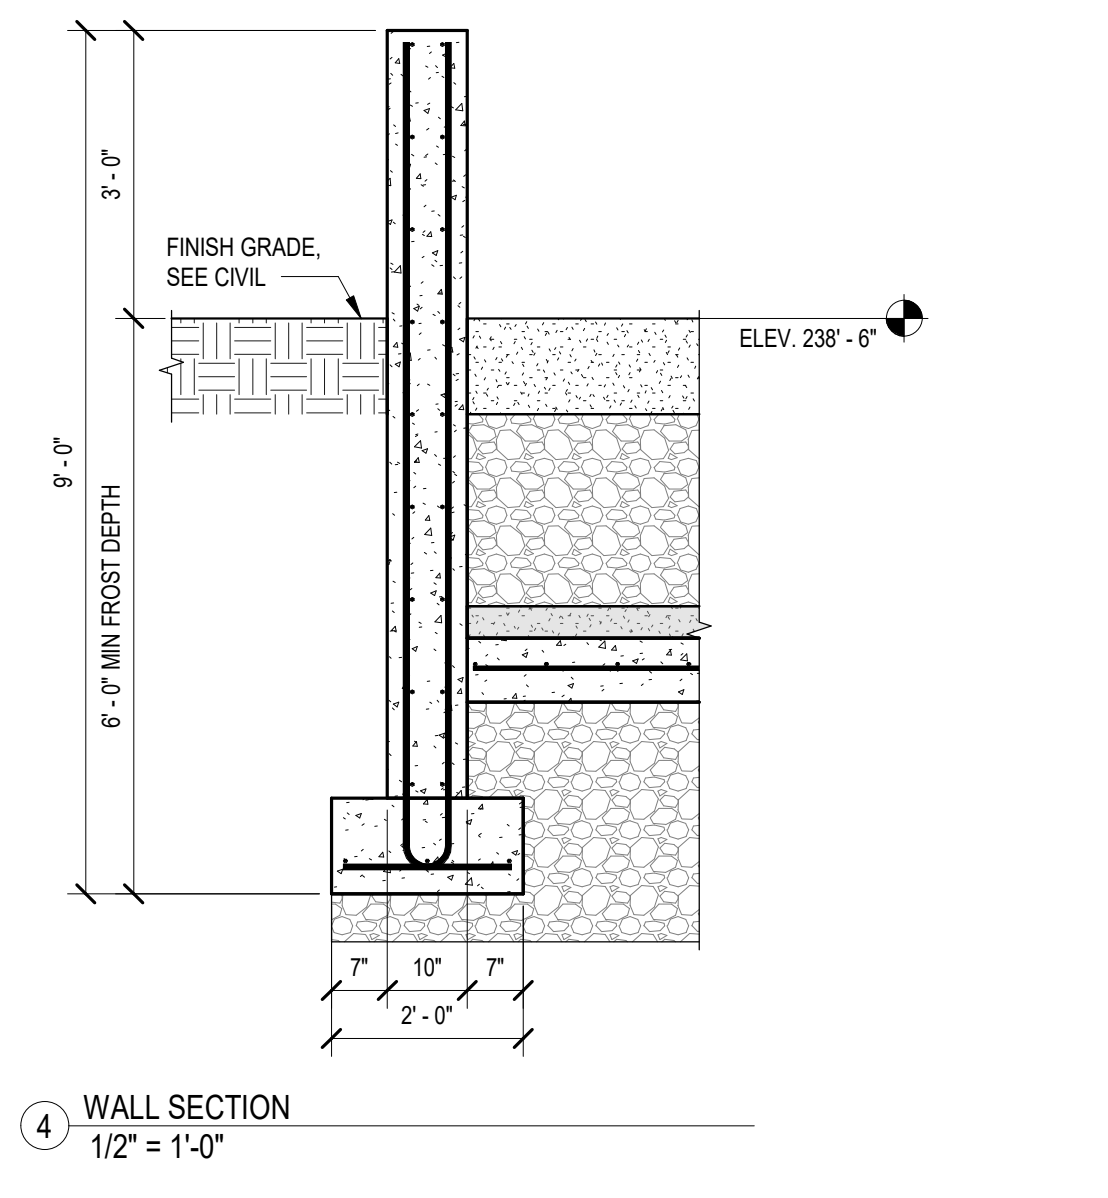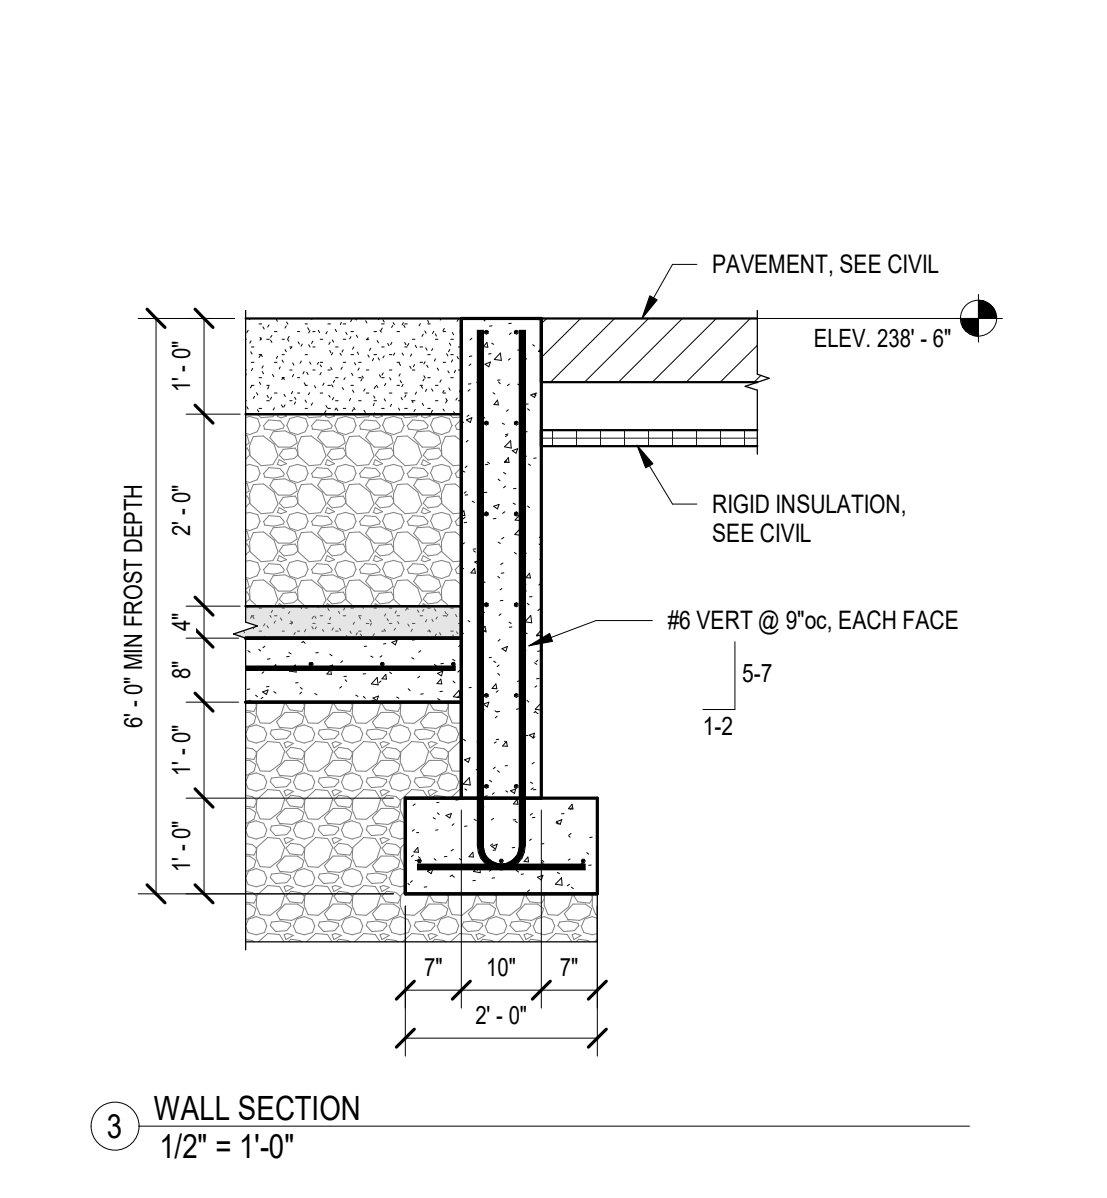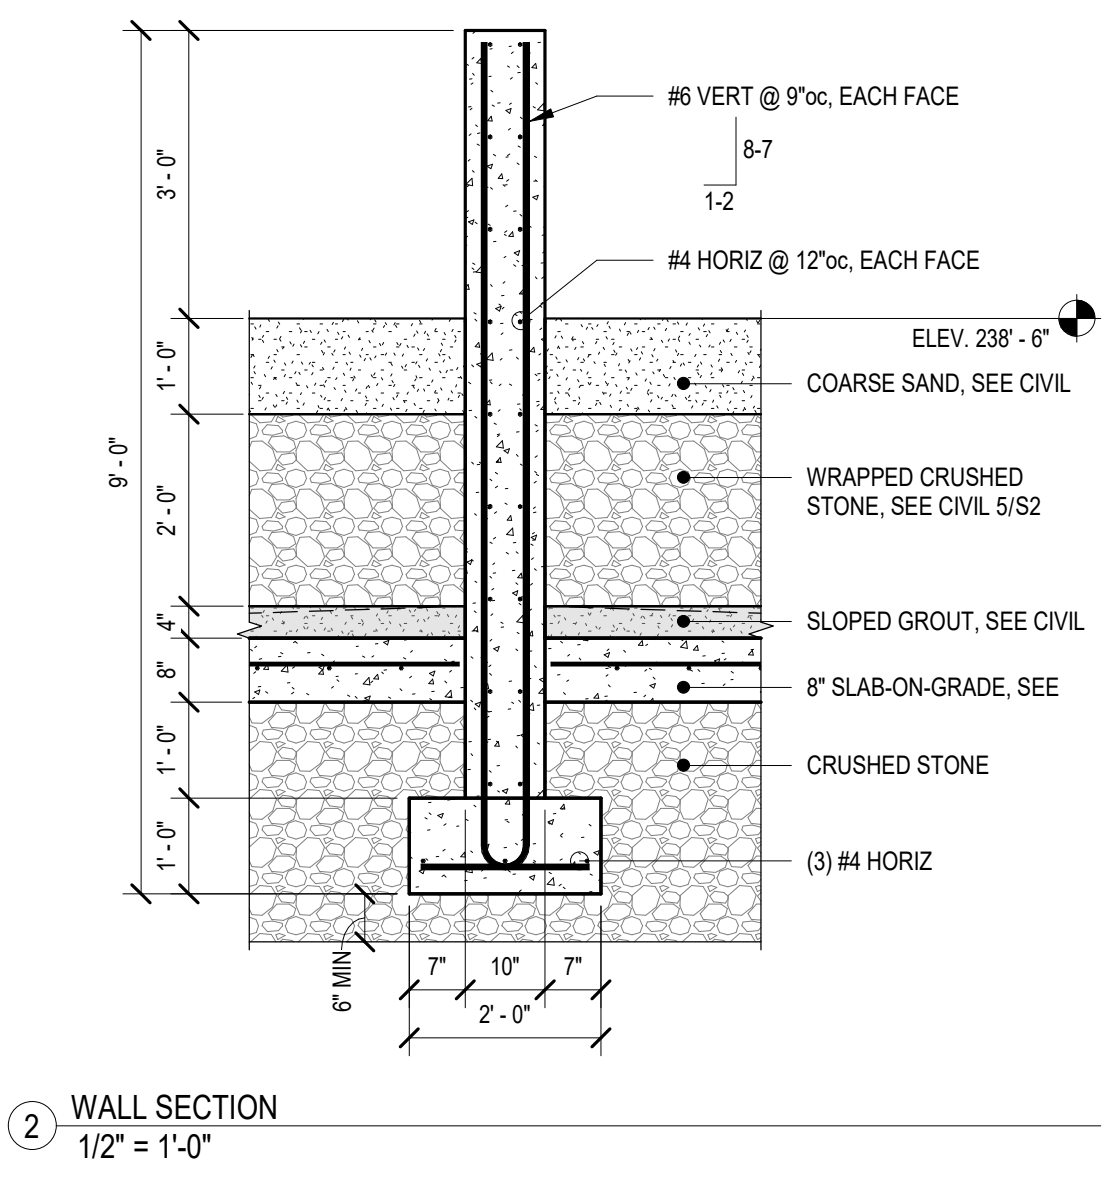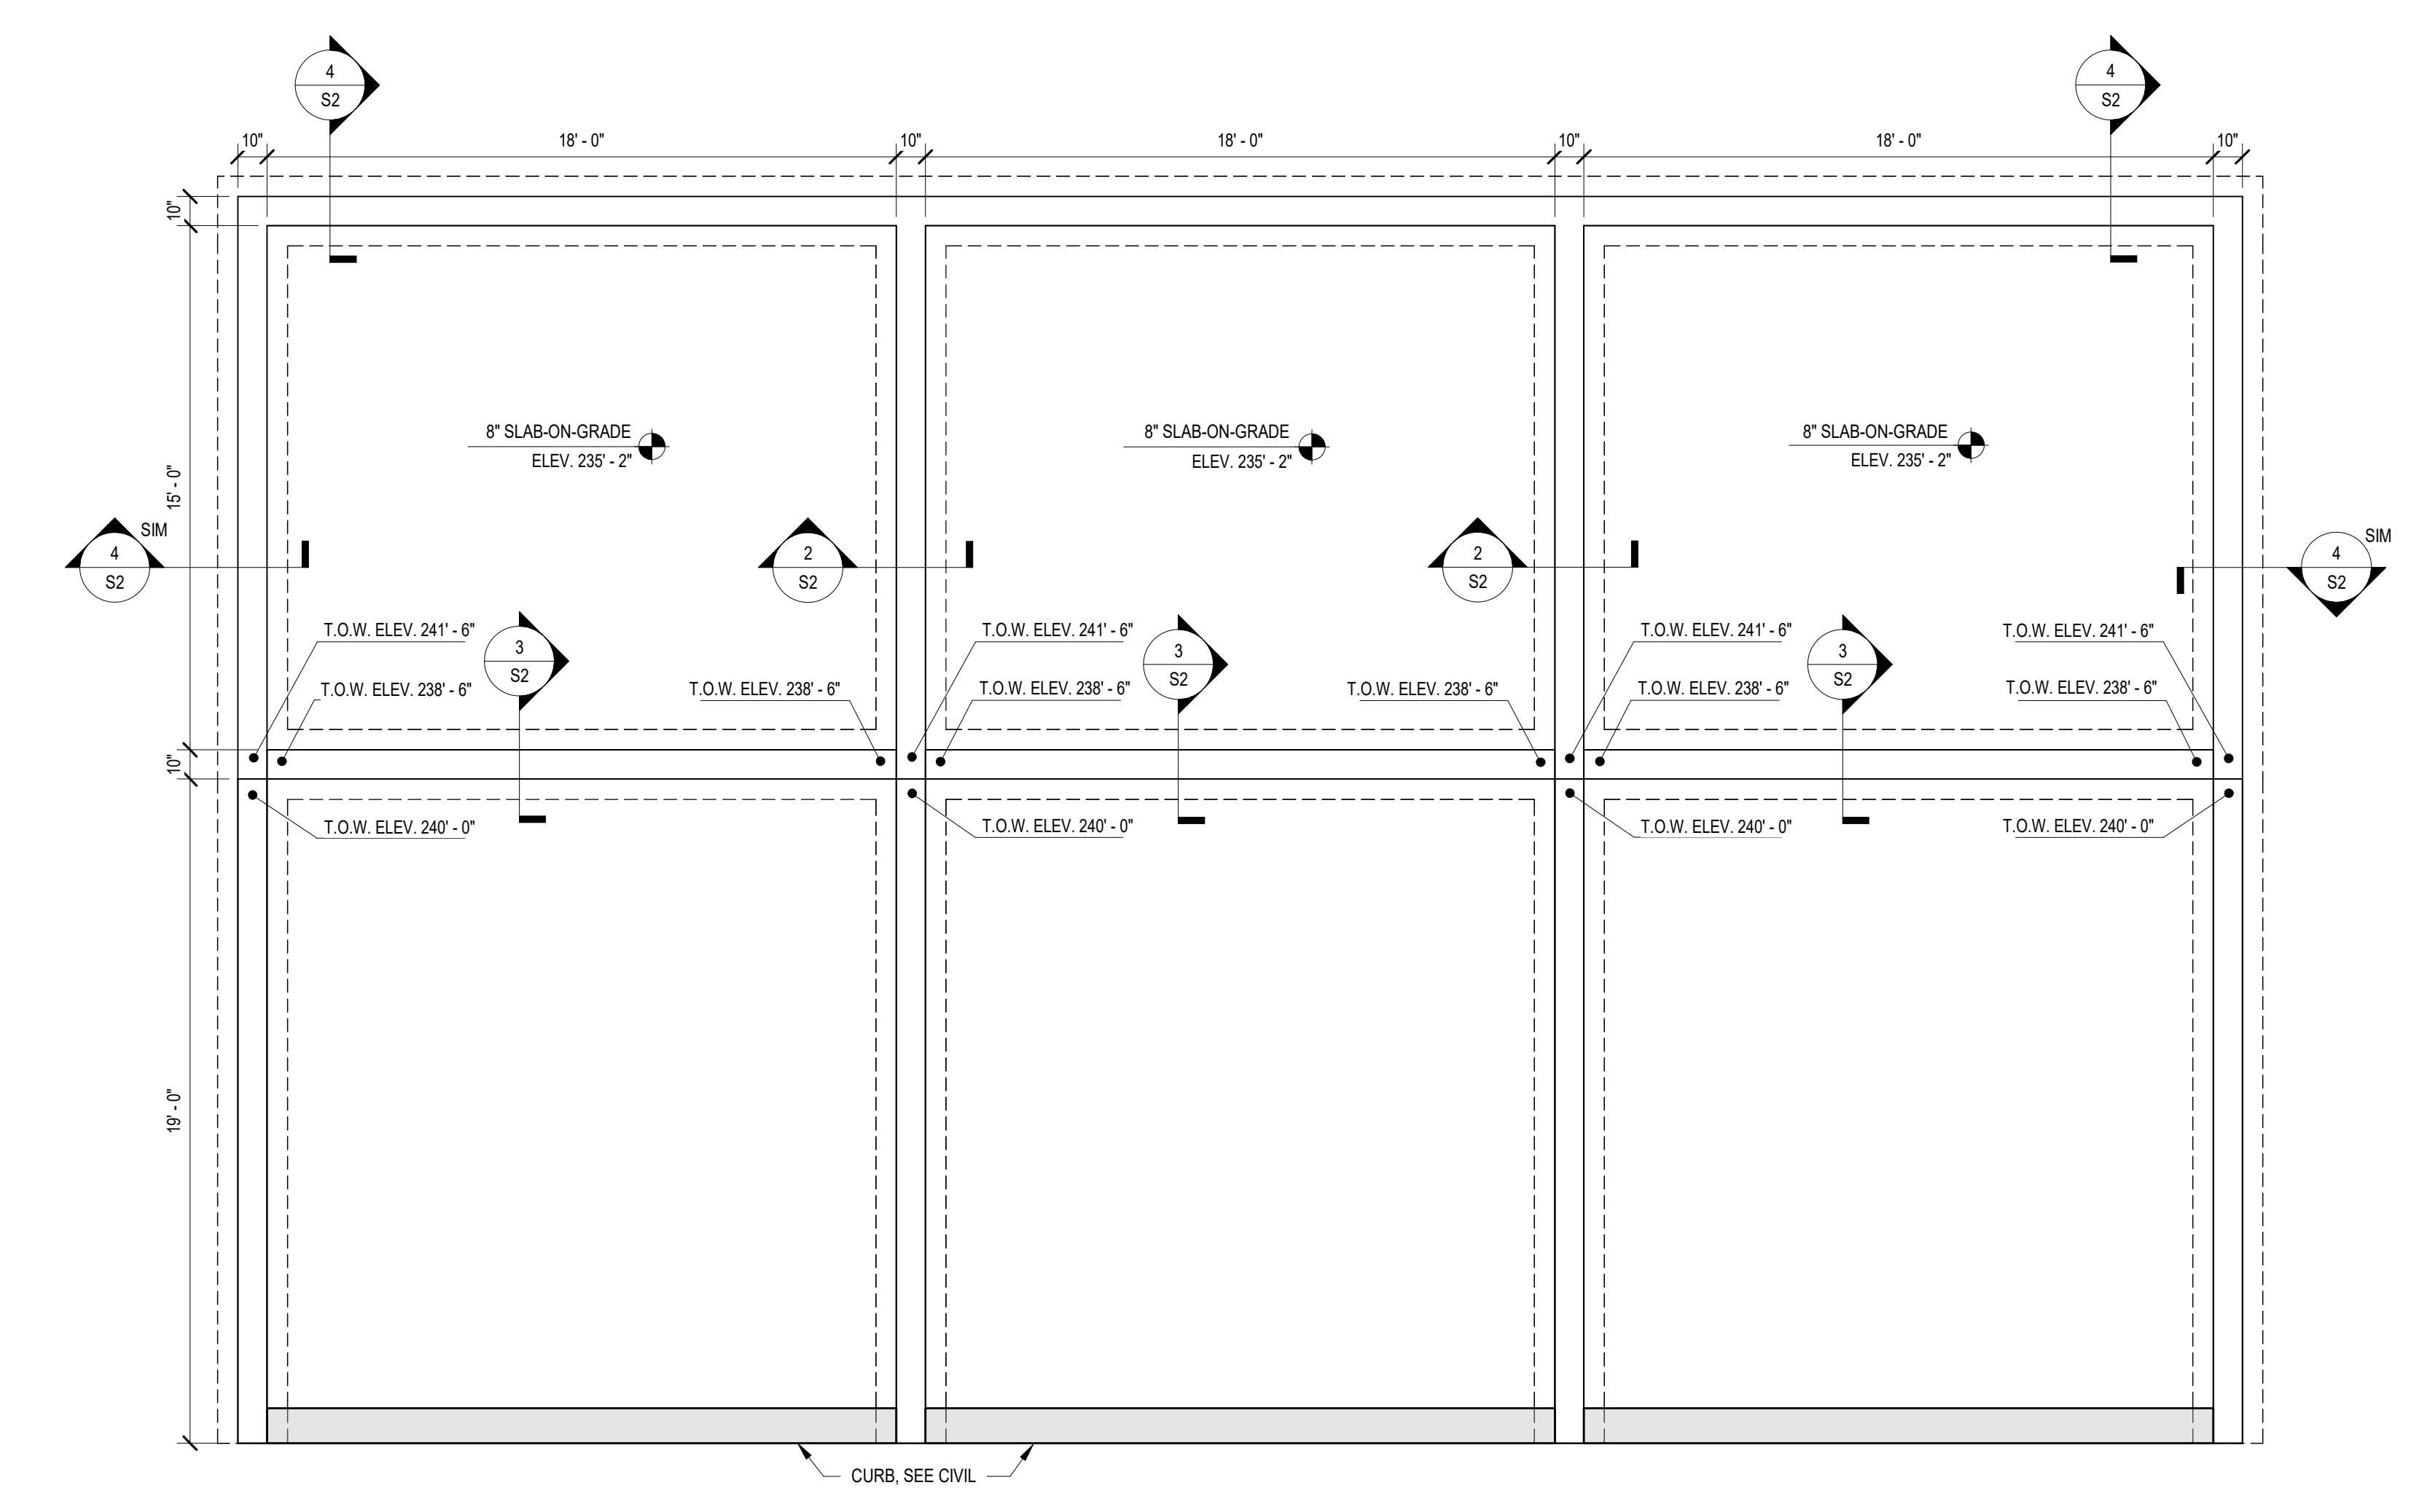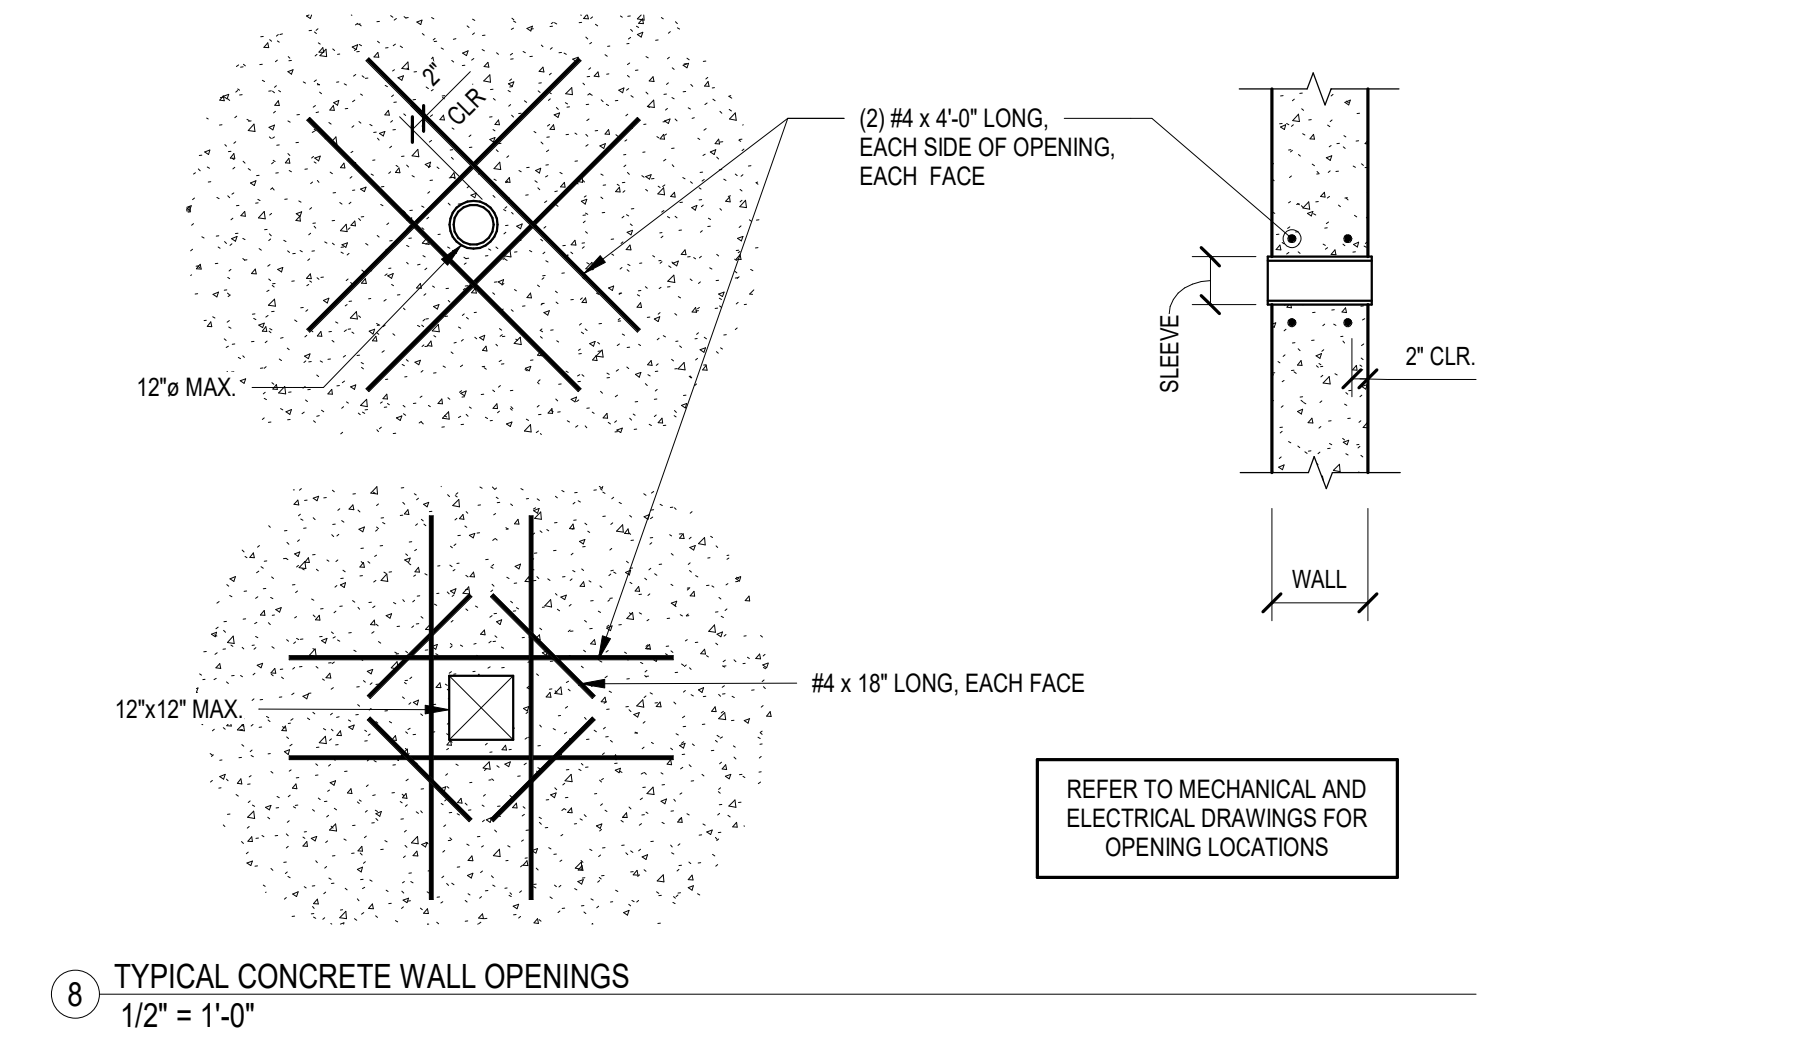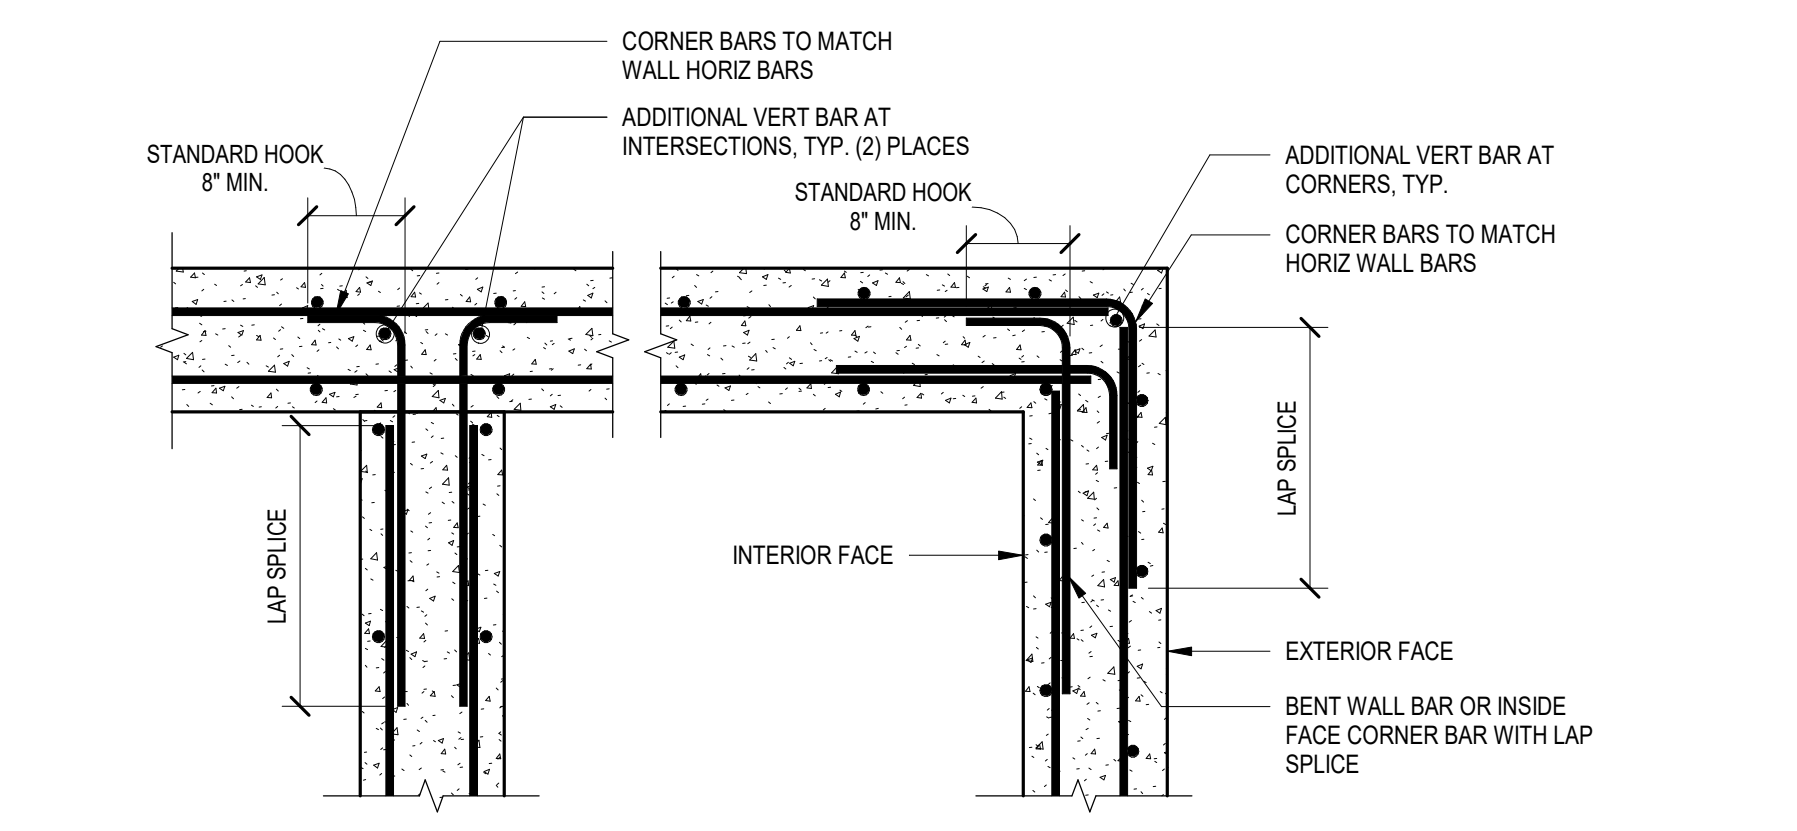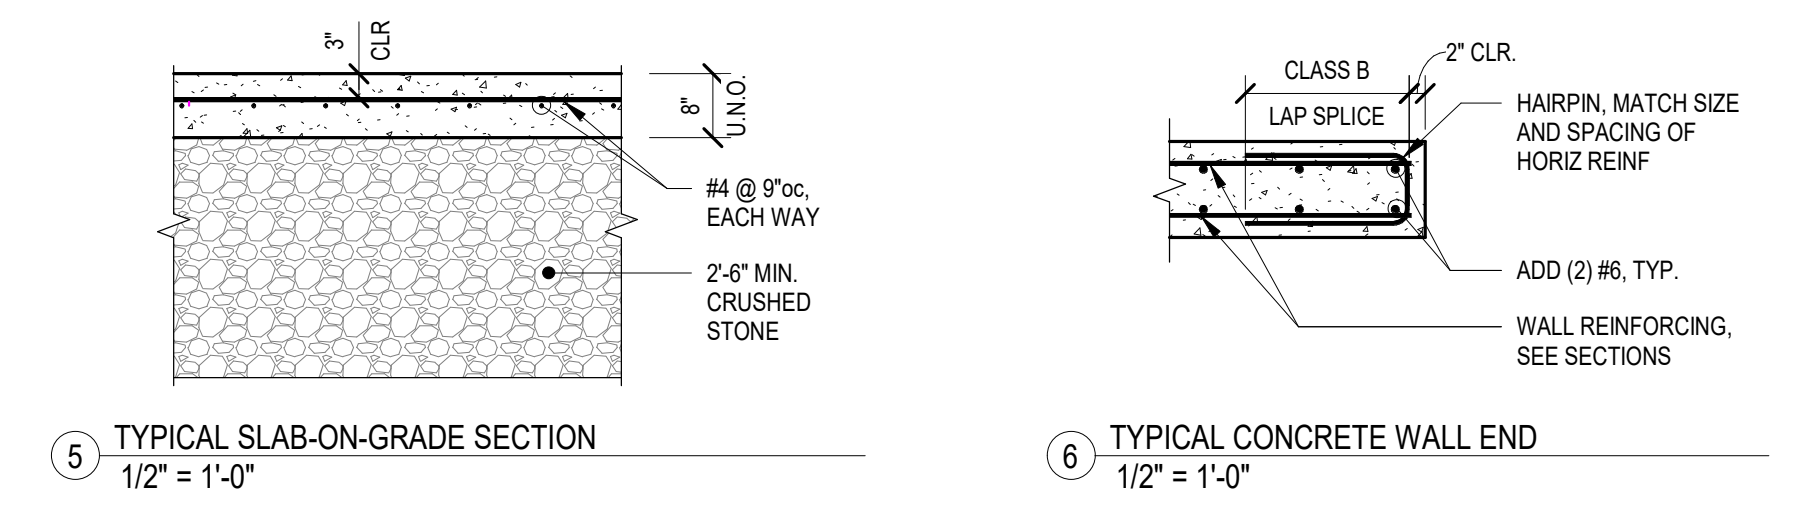

C:\Users\jvhanna\OneDrive\Work\25512_VT_Essex_WWT_Drying_Beds_DWG_0326.rvt